

# SECOND FLOOR PLAN

**NOTE**  
 this drawing is the property of  
 architects atelier/architects atelier pvt. ltd.  
 / arch tech projects pvt. ltd. & cannot  
 be altered, used or copied without the  
 written consent of architects atelier.

FILE NAME: -*servo* /


No	Date	Revision
RUBAL ELECTRIFICATION CORPORATION LTD		
PALIKA BHAWAN ,R.K PURAM,NEW DELHI		
Title INTERIOR LAY OUT		
ROUTER OF CONDUCTING		

ami.sami                      kama.sami                      s.k.sami  
 b.arch., mca                      b.arch., m.and (USA)                      b.arch., fna

Dwg No                      05

Scale  
 Date  
 PROJECT                      MARCH,2007

architects atelier  
 architects atelier pvt. ltd.  
 arch tech projects pvt. ltd.  
 sco-8, sec-17/6  
 Chandigarh-160017  
 tel: 702073,715272    mobile: 9814019753    fax: 606940

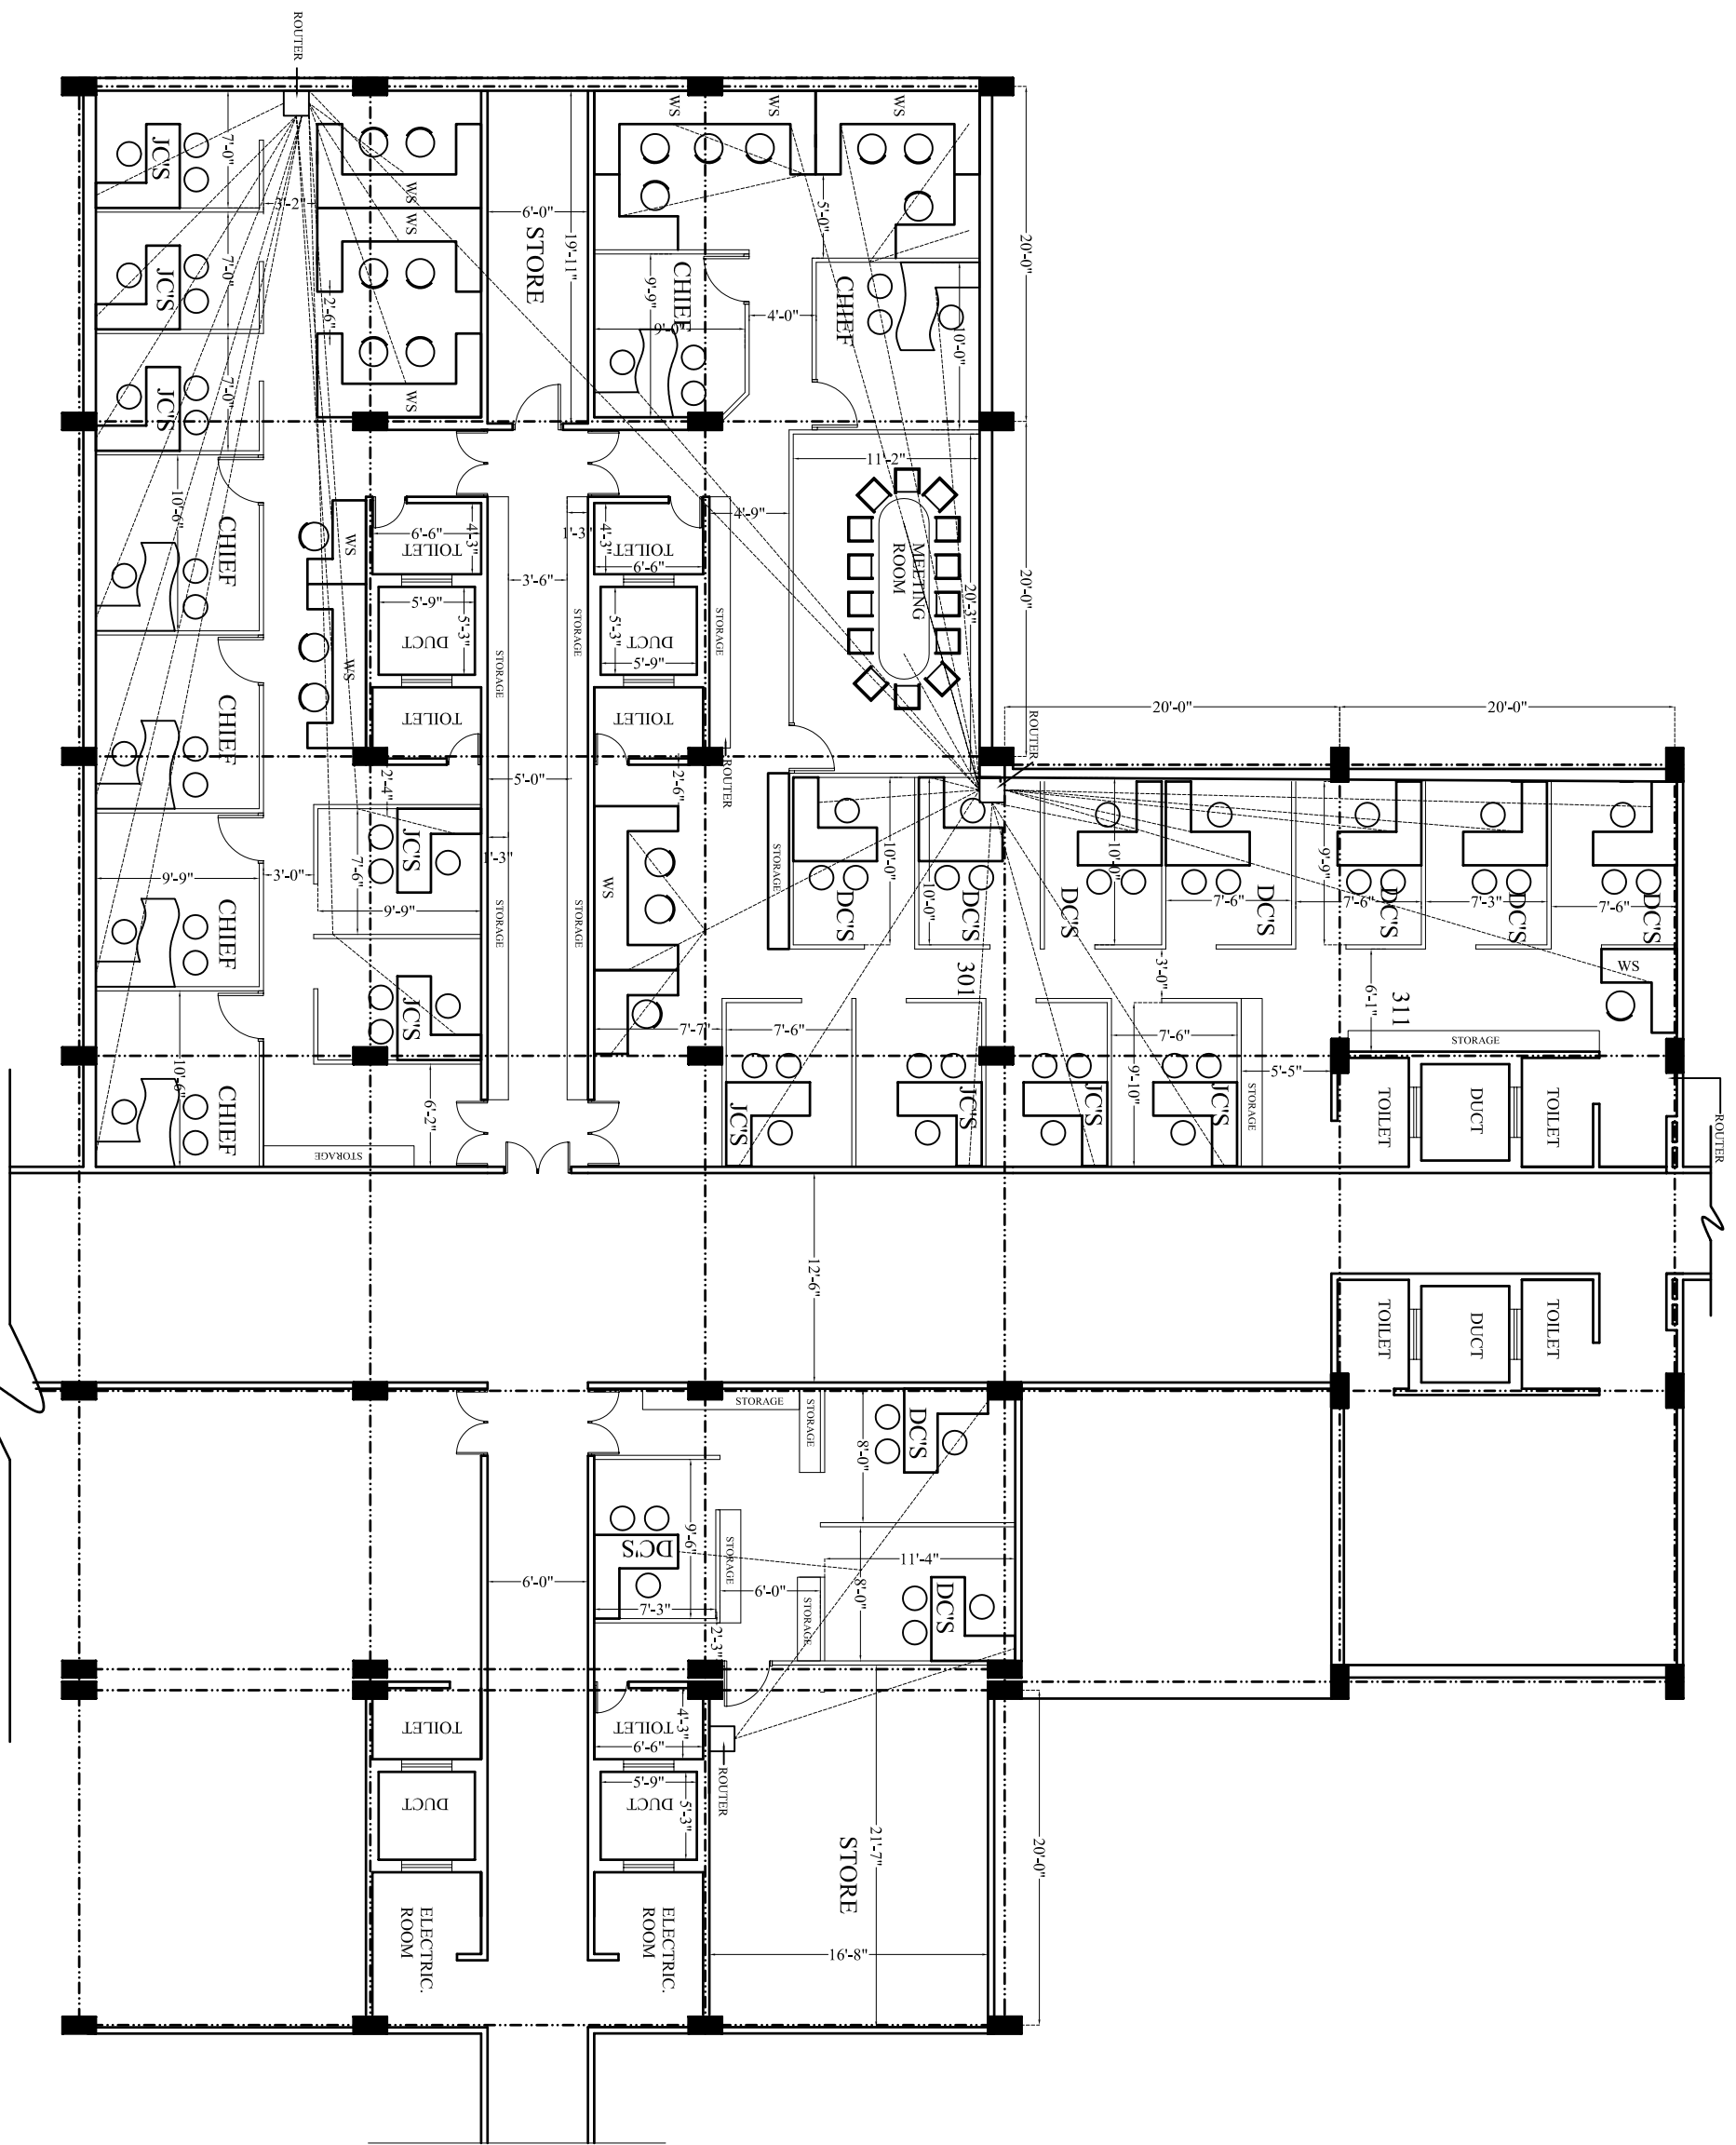

THIRDFLOOR PLAN

**NOTE**  
 this drawing is the property of  
 architects atelier/architects atelier pvt. ltd.  
 / arch tech projects pvt. ltd. & cannot  
 be altered, used or copied without the  
 written consent of architects atelier.

FILE NAME :- *servo2* /

No	Date	Revision

**RUBAL ELECTRIFICATION CORPORATION LTD**  
**PALKA BHAWAN ,R.K PURAM,NEW DELHI**  
**THE INTERIOR LAY OUT**  
**ROUTER OF CONDUCTING**

ami.sami	ketana.sami	s.k.sami
b.arch., mca	b.arch., m.and (USA)	b.arch., fia
<b>Dwg No</b>	<b>06</b>	
<b>Scale</b>		
<b>Debit</b>		<b>Date</b>
<b>PROJECT</b>		MARCH,2007

architects atelier  
 architects atelier pvt. ltd.  
 arch tech projects pvt. ltd.  
 sco-8, sec-17/6  
 Chandigarh-160017  
 tel: 702075,715272 mobile: 9814019753 fax: 606940