

# SECOND FLOOR PLAN

- ⊙ - SMOKE DETECTOR & OCCUPANCY DETECTOR
- ⊕ - SPOT LIGHT
- ⊗ - 2X2' LIGHT
- ☐ - SPLIT AC

**NOTE**  
 this drawing is the property of architects atelier/architects atelier pvt. ltd. / arch tech projects pvt. ltd. & cannot be altered, used or copied without the written consent of architects atelier.

FILE NAME: - 2017/03/15/272


No	Date	Revision
RUBAL ELECTRIFICATION CORPORATION LTD		
PALIKA BHAWAN ,R.K PURAM,NEW DELHI		
Title INTERIOR LAY OUT		
FALSE CEILING PLAN		

ami.sami kama.sami s.k.sami  
 b.arch., mca b.arch., m.and (USA) b.arch., fia

Dwg No 03

Scale	Date
Debit	MARCH,2007
SIML	

architects atelier  
 architects atelier pvt. ltd.  
 arch tech projects pvt. ltd.  
 sco-8, sec-17/ie  
 Chandigarh - 160017  
 tel: 7020753,715272 mobile: 9814019753 fax: 6068940

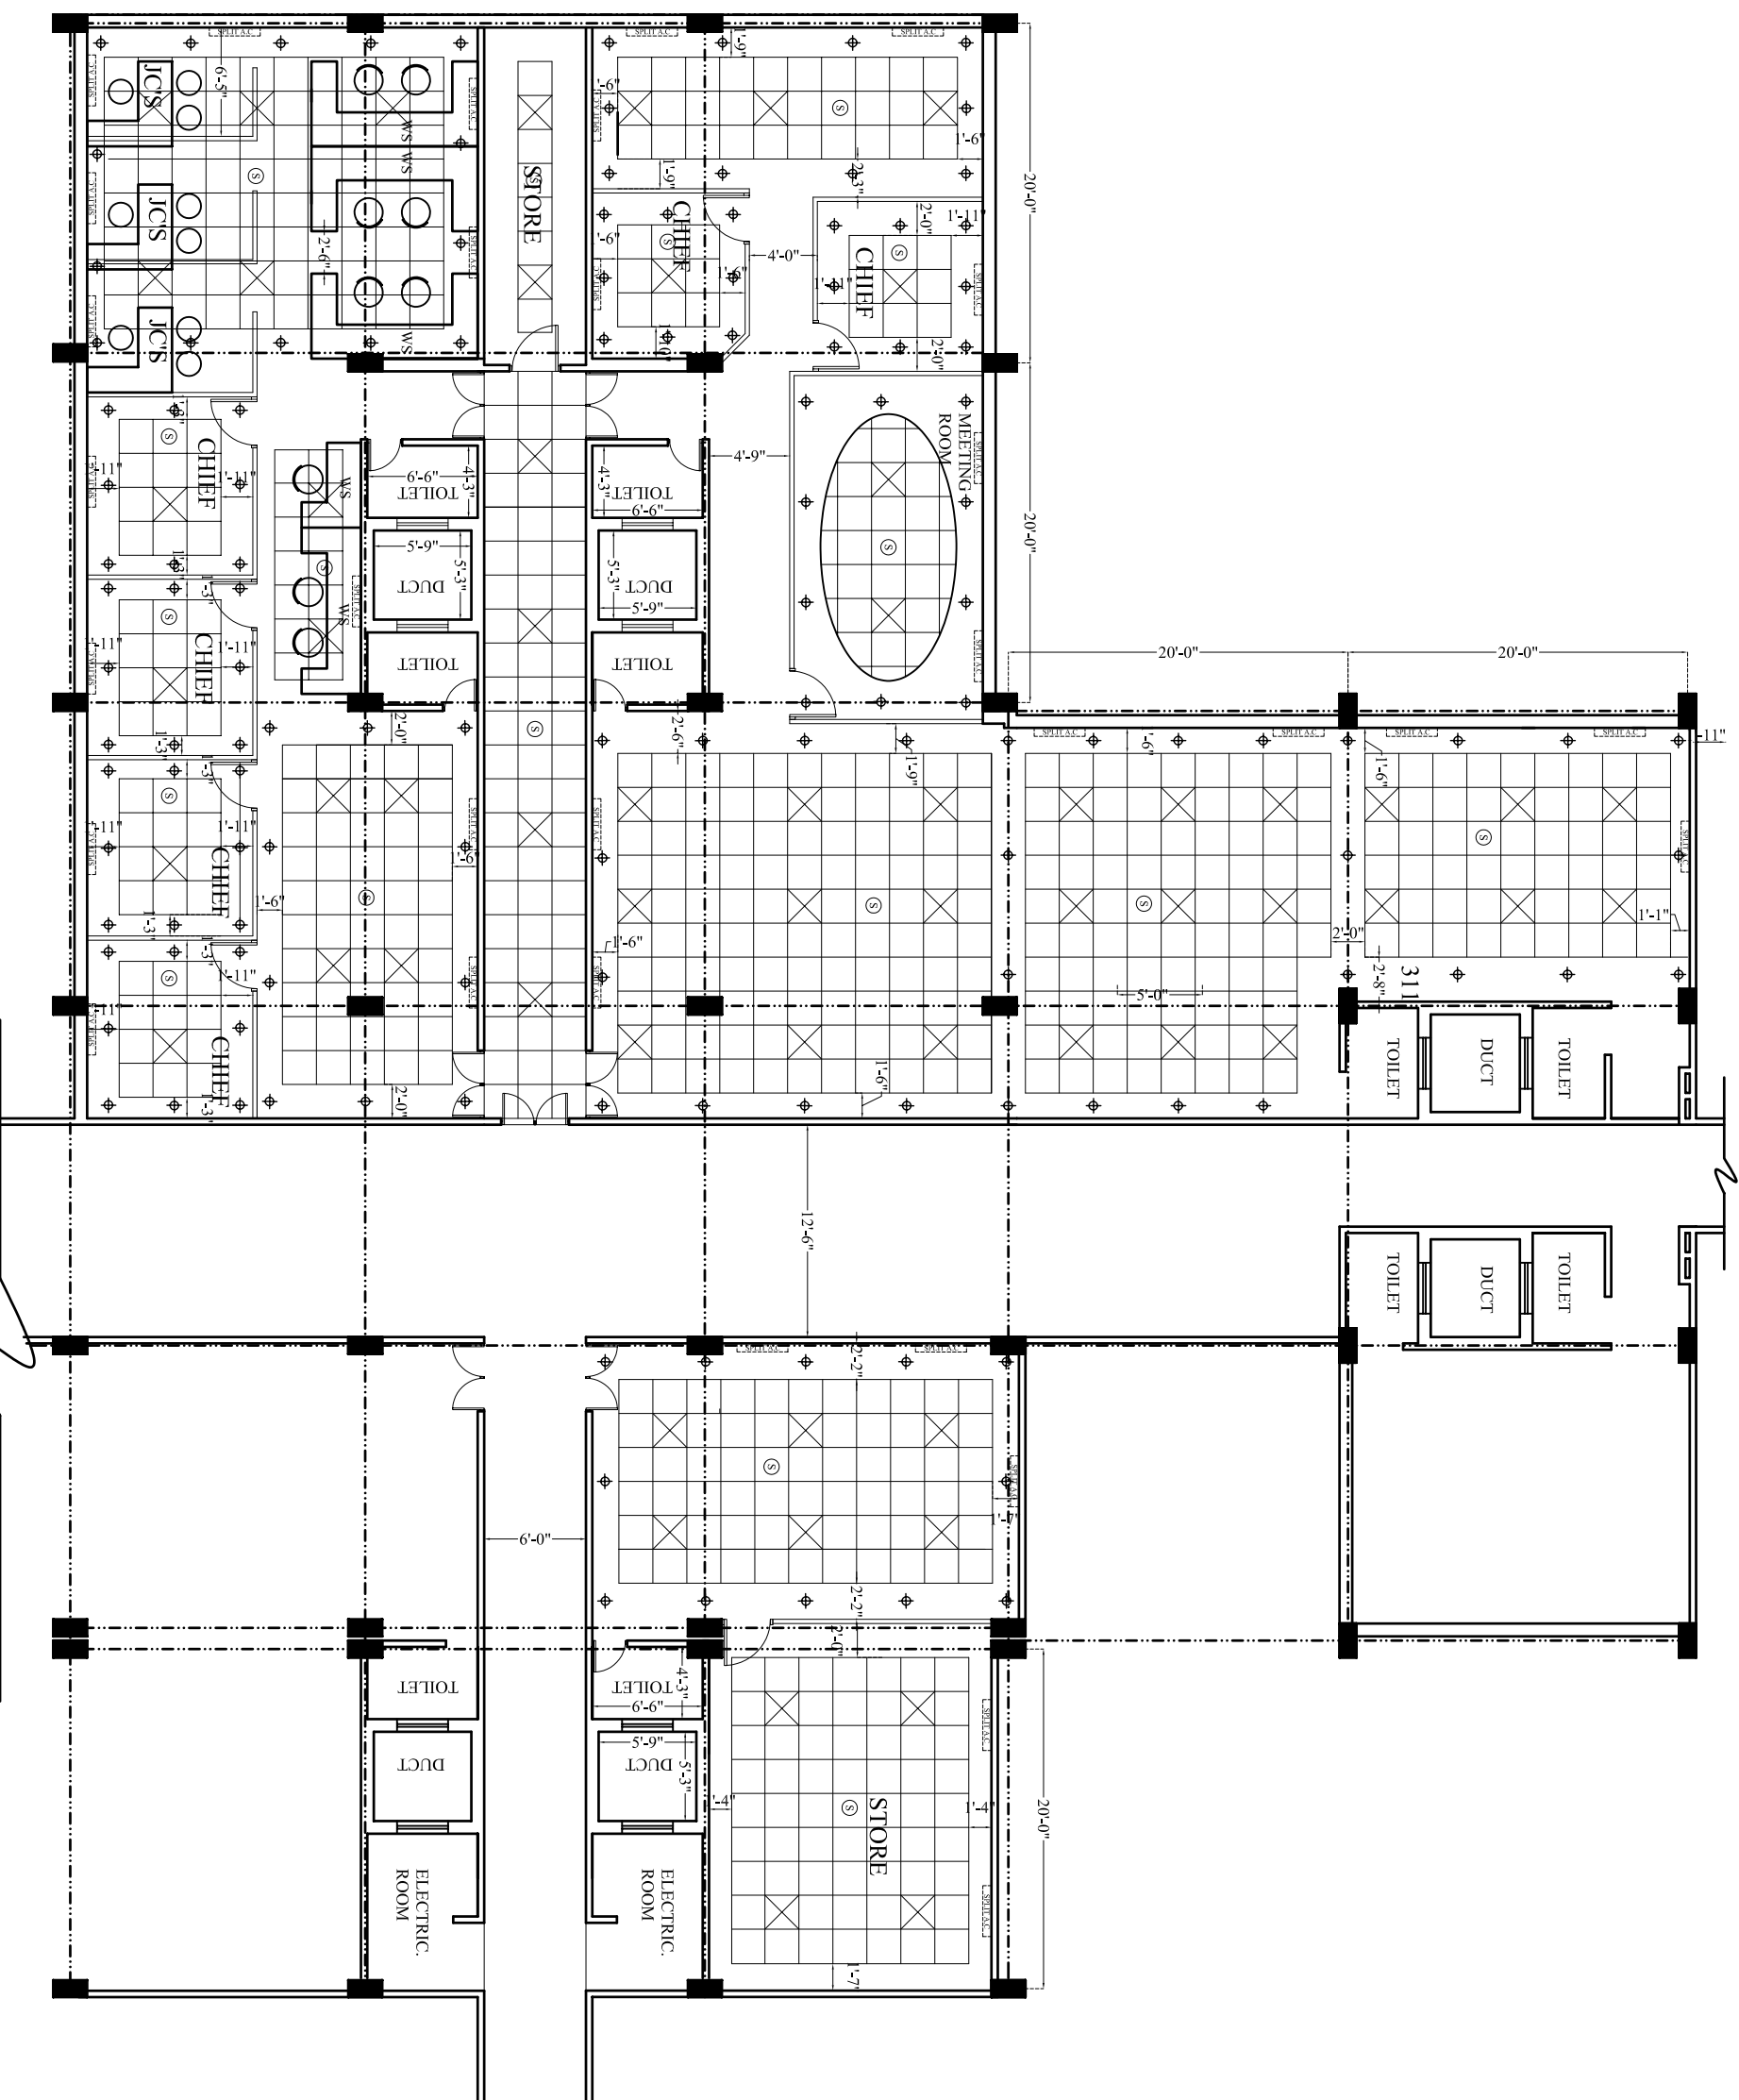

# THIRDFLOOR PLAN

- ⊙ - SMOKE DETECTOR & OCCUPANCY DETECTOR
- ⊕ - SPOT LIGHT
- ⊗ - 2X2 LIGHT
- ⊞ - SPLIT AC

## NOTE

this drawing is the property of architects atelier/architects atelier pvt. ltd. / arch tech projects pvt. ltd. & cannot be altered, used or copied without the written consent of architects atelier.

FILE NAME :- 3rd floor /

No	Date	Revision

**RURAL ELECTRIFICATION CORPORATION LTD  
PALIKA BHAWAN ,R.K PURAM,NEW DELHI**

**THE INTERIOR LAY OUT  
FALSE CEILING PLAN**

amit samir	krishna samir	s.k samir
b.arch., mca	b.arch., m.and (USA)	b.arch., fia
<b>Dwg No</b>	<b>04</b>	
<b>Scale</b>		
<b>Debit</b>		<b>Date</b>
<b>SMIL</b>		<b>MARCH 2007</b>

architects atelier  
architects atelier pvt. ltd.  
arch tech projects pvt. ltd.  
scs-8, sec-17/6  
Gurgaon-160017  
tel: 702075715272 mobile: 9814019753 fax: 6069940